


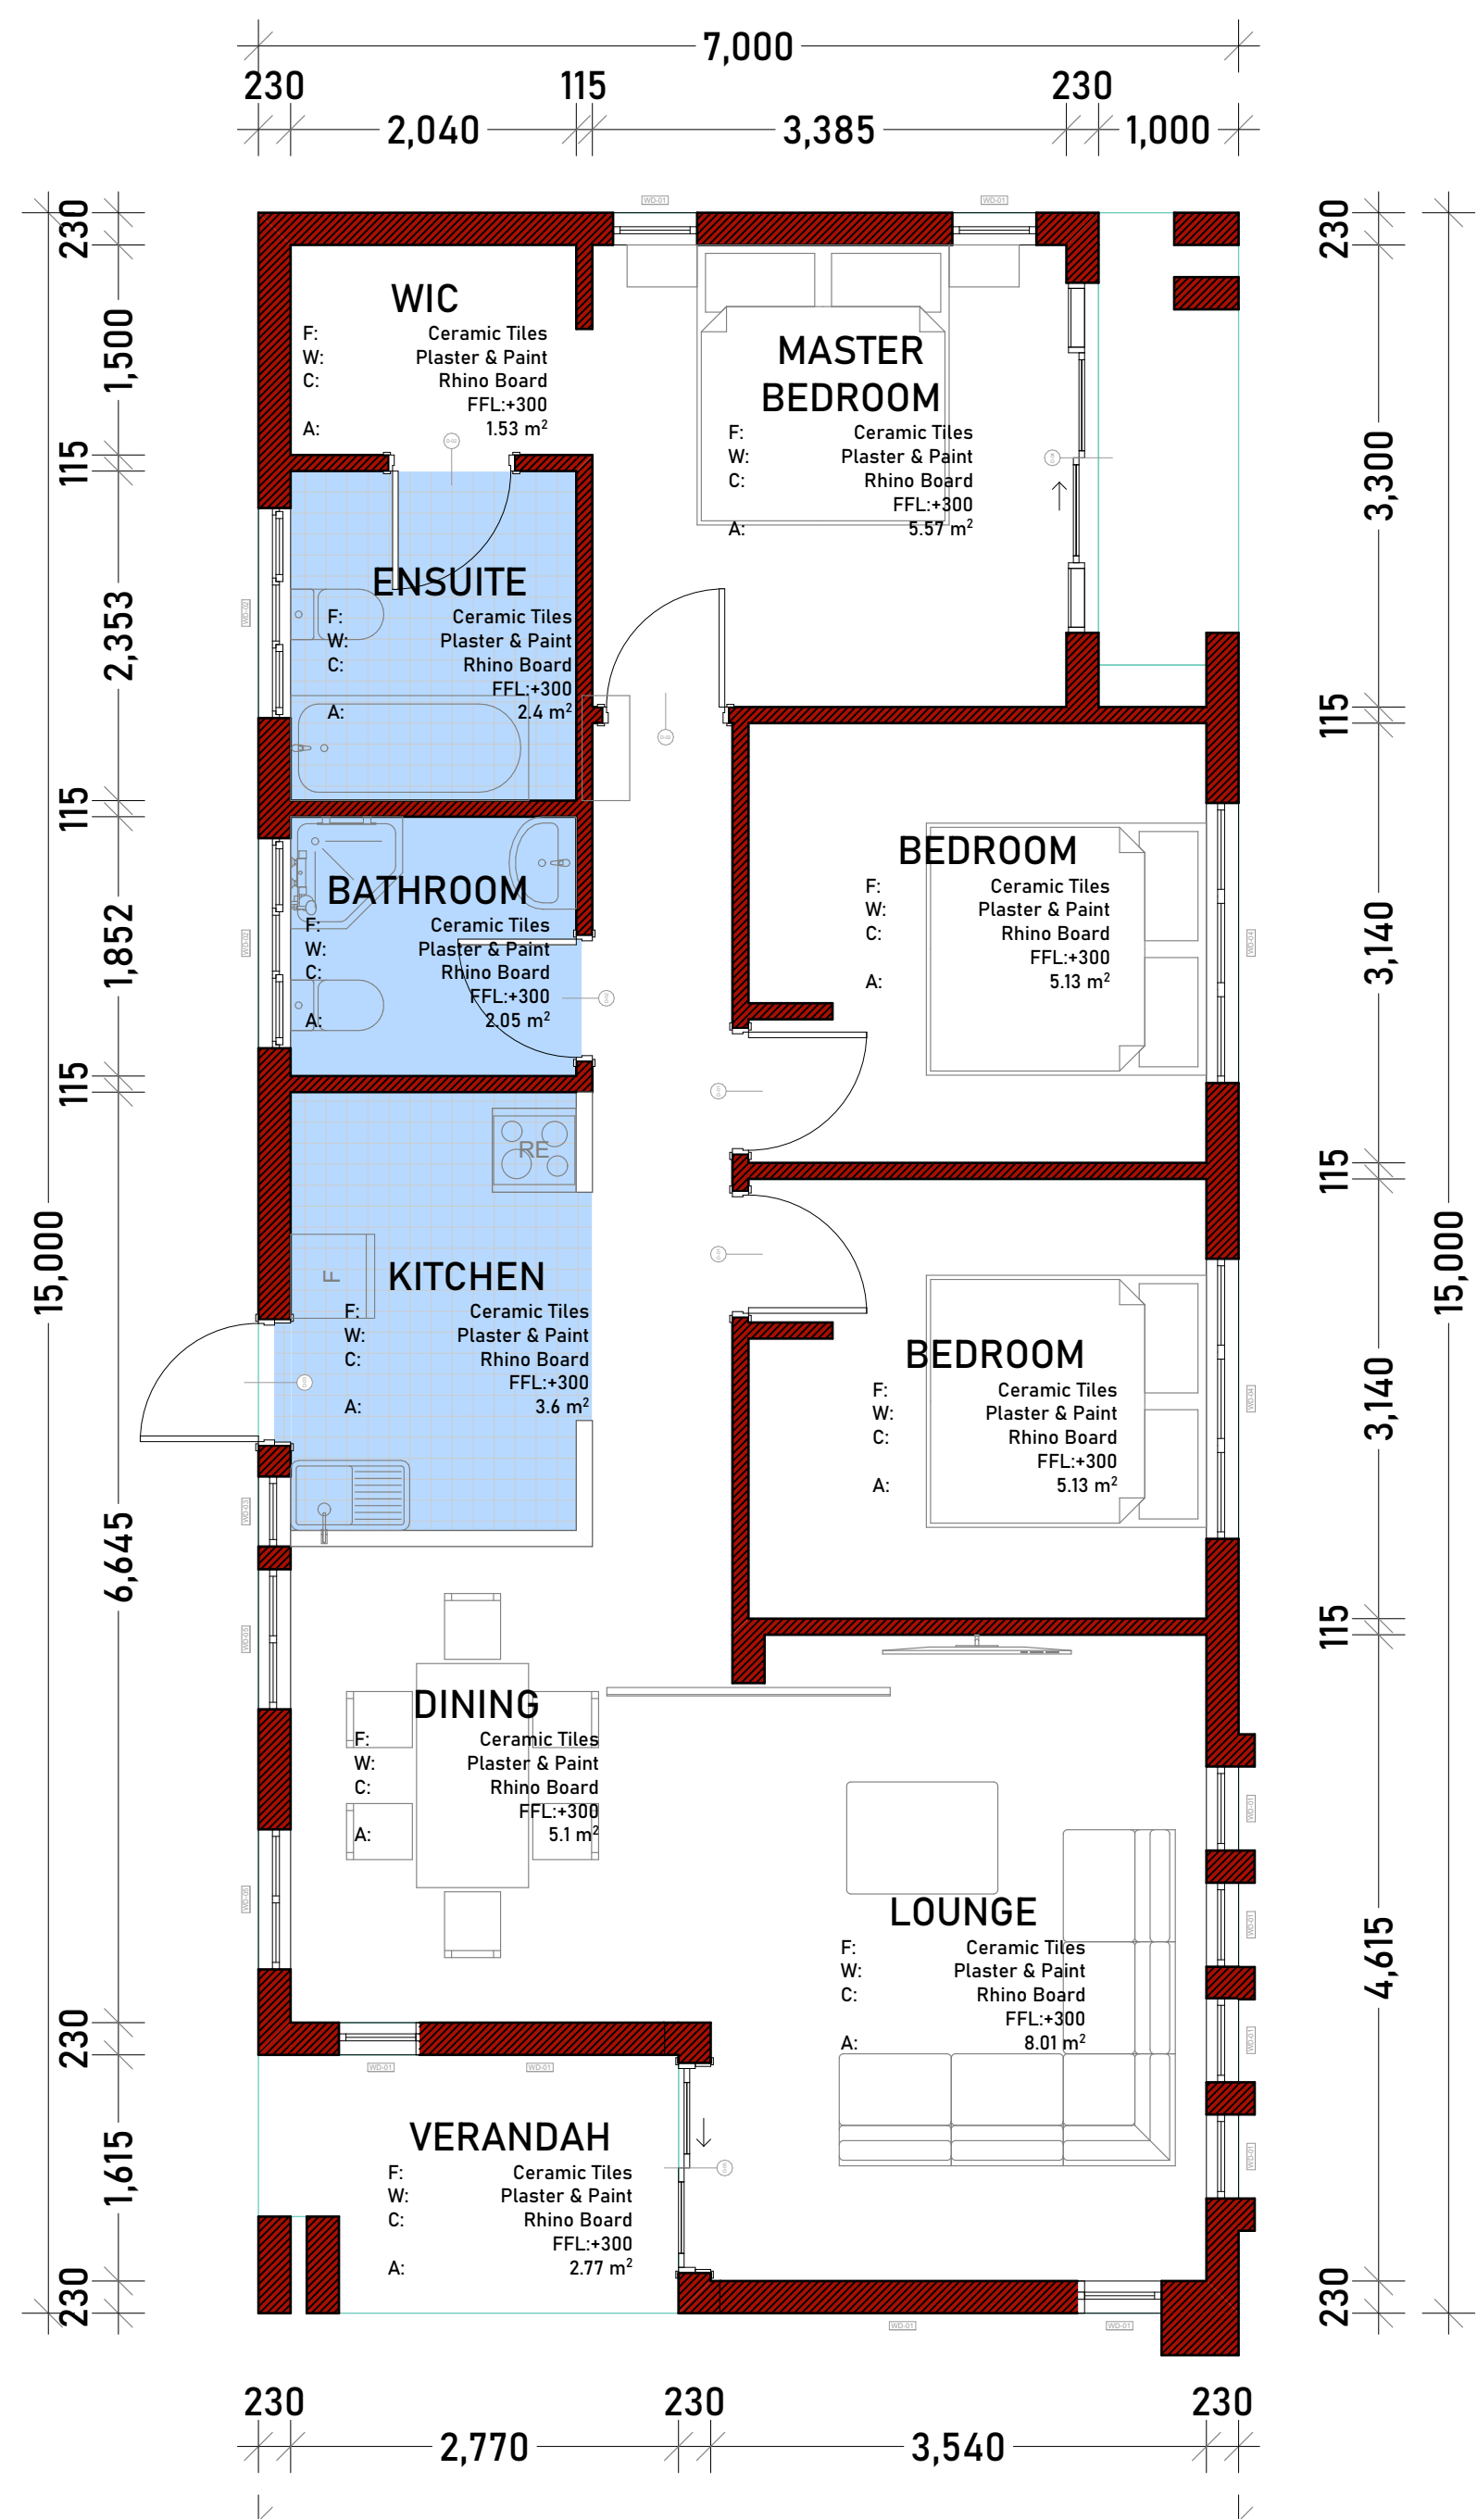

0. UNIT 05 FLOOR PLAN 1:50



DESIGN DRAWINGS			Client MCM	
			Title CLUSTER UNIT DESING 05	
				ROOF PLAN
				Scale 1:50
				Designed And Drawn K.B.C
Rev	Date	Description	Approved	Dwg No
				Checked By K.B.C

